




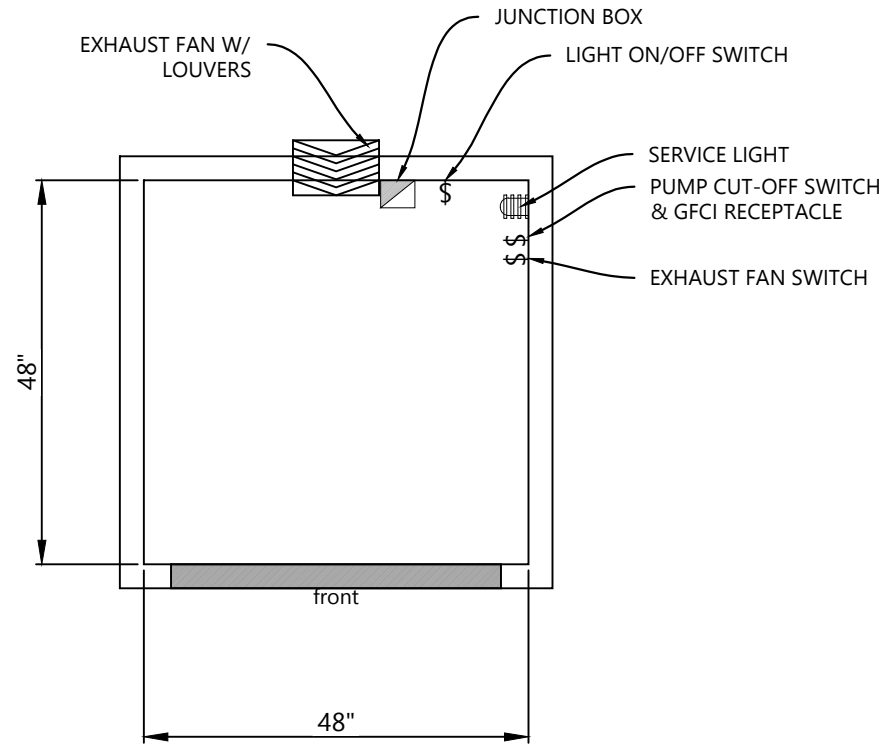

EQUIPMENT PLAN

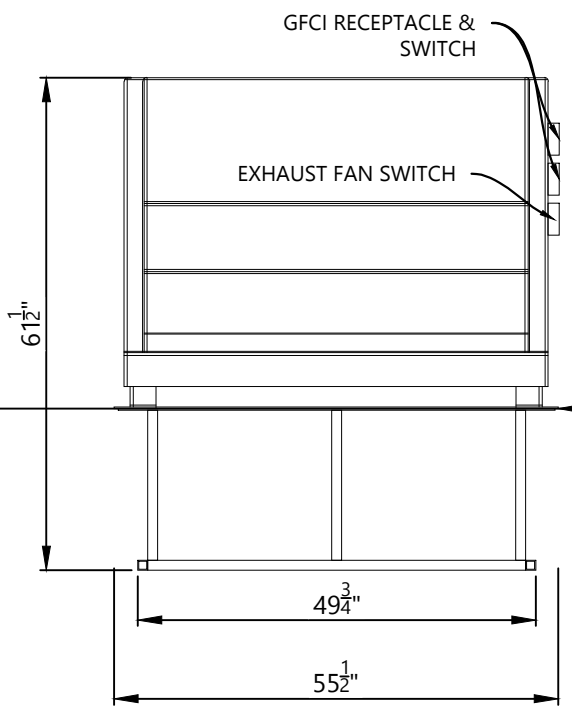

EQUIPMENT PACK FRONT ELEVATION

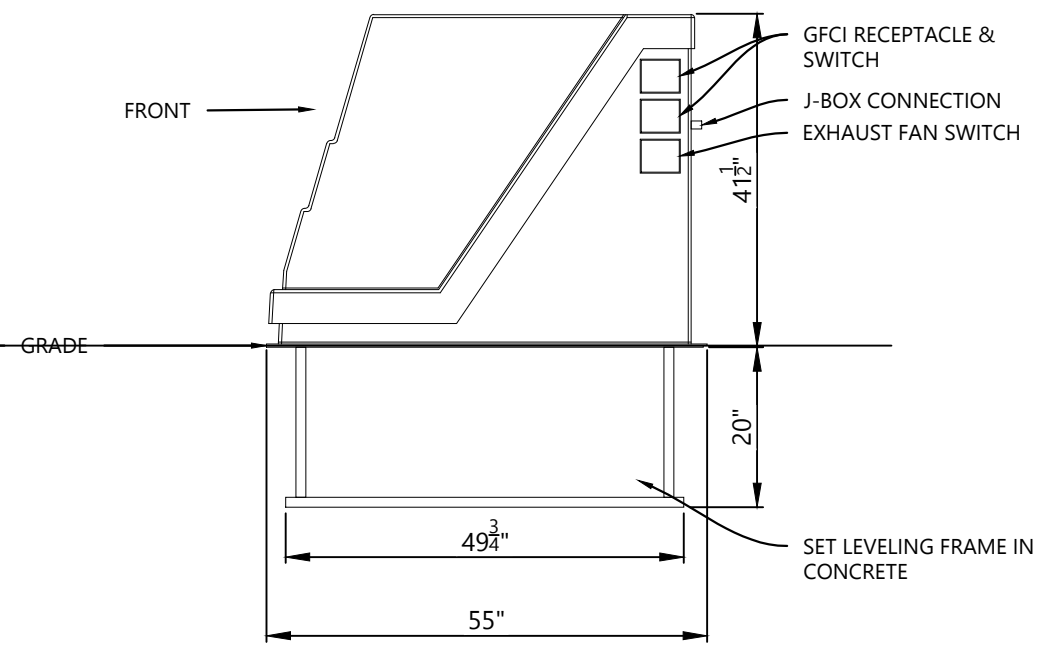

EQUIPMENT PACK SIDE ELEVATION

EQUIPMENT		
ITEM	DESCRIPTION	ELECTRICAL
FILTER PUMP		
FILTER		
CONTROLLER		
CHLORINE FEEDER		
ACID FEEDER		
UV SYSTEM		
FEATURE PUMP		
SERVICE LIGHT	100W LIGHT	115V / 1ϕ / 1.5A
GFCI OUTLET & TIME CLOCK	INCLUDED	115V / 1ϕ / 20A

- EQUIPMENT GENERAL NOTES**
1. DRAWINGS COMPLY WITH STATE & LOCAL BUILDING CODES.
 2. ALL ELECTRICAL/LIGHTING PER LATEST EDITION NEC.
 3. ALL EQUIPMENT BELOW STATIC WATER ELEVATION IS TO HAVE POSITIVE VALVE SHUT OFF FOR SERVICE.
 4. ALL PIPING 'NSF-PW' APPROVED.
 5. ALL ELECTRICAL CHEMICAL FEEDERS & UV LAMPS ARE TO BE ELECTRICALLY INTERLOCKED WITH THE RECIRCULATION PUMP.
 6. ALL EROSION FEEDERS ARE TO BE HYDRAULICALLY INTERLOCKED WITH THE RECIRCULATION PUMP.
 7. PROPORTIONING VALVES ONLY - GATE VALVES ARE PROHIBITED.
 8. ALL TANKS HAVE COVED CORNERS AND SLOPE TO DRAINS.
 9. ALL EQUIPMENT IS UL LISTED, NSF-50.
 10. ALL PIPE SUBJECT TO UV EXPOSURE IS TO BE COATED TO PROVED AGAINST UV DEGRADATION.
 11. ALL WASTE LINES MUST INCLUDE AN AIR GAP.
 12. WASTE LINE MUST BE CONNECTED TO APPROVED SEWER SYSTEM IN ACCORDANCE WITH STATE & LOCAL CODES.



WWW.SEGAQUATICS.COM
MCWSEG@GMAIL.COM
813.431.7063

ALL INFORMATION CONTAINED IN THIS DOCUMENT IS PROPERTY OF SEG, INC AND MAY NOT BE REPRODUCED OR COMMUNICATED WITHOUT PRIOR PERMISSION IN WRITING FROM SEG, INC. ALL DESIGN SPECIFICATIONS & COMPONENTS ARE SUBJECT TO CHANGE WITHOUT NOTICE. PLEASE CONSULT OUR WEBSITE FOR UP TO DATE ENGINEERING DRAWINGS.

DATE	Jul. 5, 26
SCALE	1/2" = 1'-0"
REVISION	A
PROJECT	
CONTRACTOR	
LOCATION	

SHEET TITLE
EQ 4X4